

INDEX OF DRAWINGS:

- 1 FRONT AND REAR EXTERIOR ELEVATIONS
- 2 SIDE EXTERIOR ELEVATIONS
- 3 LOWER FLOOR PLAN, DOOR AND WINDOW SCHEDULE
- 4 INTERIOR ELEVATIONS
- 5 UPPER FLOOR PLAN, UPPER ELECTRICAL PLAN
- 6 LOWER ELECTRICAL PLAN
- 7 ROOF PLAN, DETAILS



FRONT ELEVATION
SCALE: 1/4" = 1'-0"



REAR ELEVATION
SCALE: 1/4" = 1'-0"

NOTE: IT IS THE SOLE RESPONSIBILITY OF THE BUILDER TO VERIFY ALL ASPECTS OF THIS PLAN AND TO ENSURE THAT THIS PLAN MEETS ALL GOVERNING CODES & REQUIREMENTS.

These plans are the property of "Direct Home Design" and are not to be reproduced, traced or reused without the written permission of "Direct Home Design". It shall be the responsibility of the builder/owner to verify all local restrictions, Building Codes & Dimensions prior to any construction.



Direct Home Design
P.O. BOX 48631
Watauga, TX 76148
(817)917-4516

DESCRIPTION

SQUARE FOOTAGE:	
LIVING:	3113
FRONT PORCH:	187
REAR PORCH:	168
VERANDAH:	509
GARAGE+SHOP:	1118
ATTIC:	125
TOTAL U/R:	5820

PROPERTY ADDRESS:

416 SANDY LANE
FORT WORTH, TX 76120

Drawn WB
Date 4-8-16

PLAN NO.

BRIGHT

PG. 1 OF 7

These plans are the property of "Direct Home Design" and are not to be reproduced, traced or reused without the written permission of "Direct Home Design". It shall be the responsibility of the builder/owner to verify all local restrictions, Building Codes & Dimensions prior to any construction.



Direct Home Design
P.O. BOX 48631
Watauga, TX 76148
(817)917-4516

DESCRIPTION

SQUARE FOOTAGE:	
LIVING:	3113
FRONT PORCH:	187
REAR PORCH:	168
VERANDAH:	509
GARAGE+SHOP:	1118
ATTIC:	125
TOTAL U/R:	5820

PROPERTY ADDRESS:


416 SANDY LANE
FORT WORTH, TX 76120

Drawn WB
Date 4-8-16


PLAN NO.

BRIGHT

PG. 2 OF 7

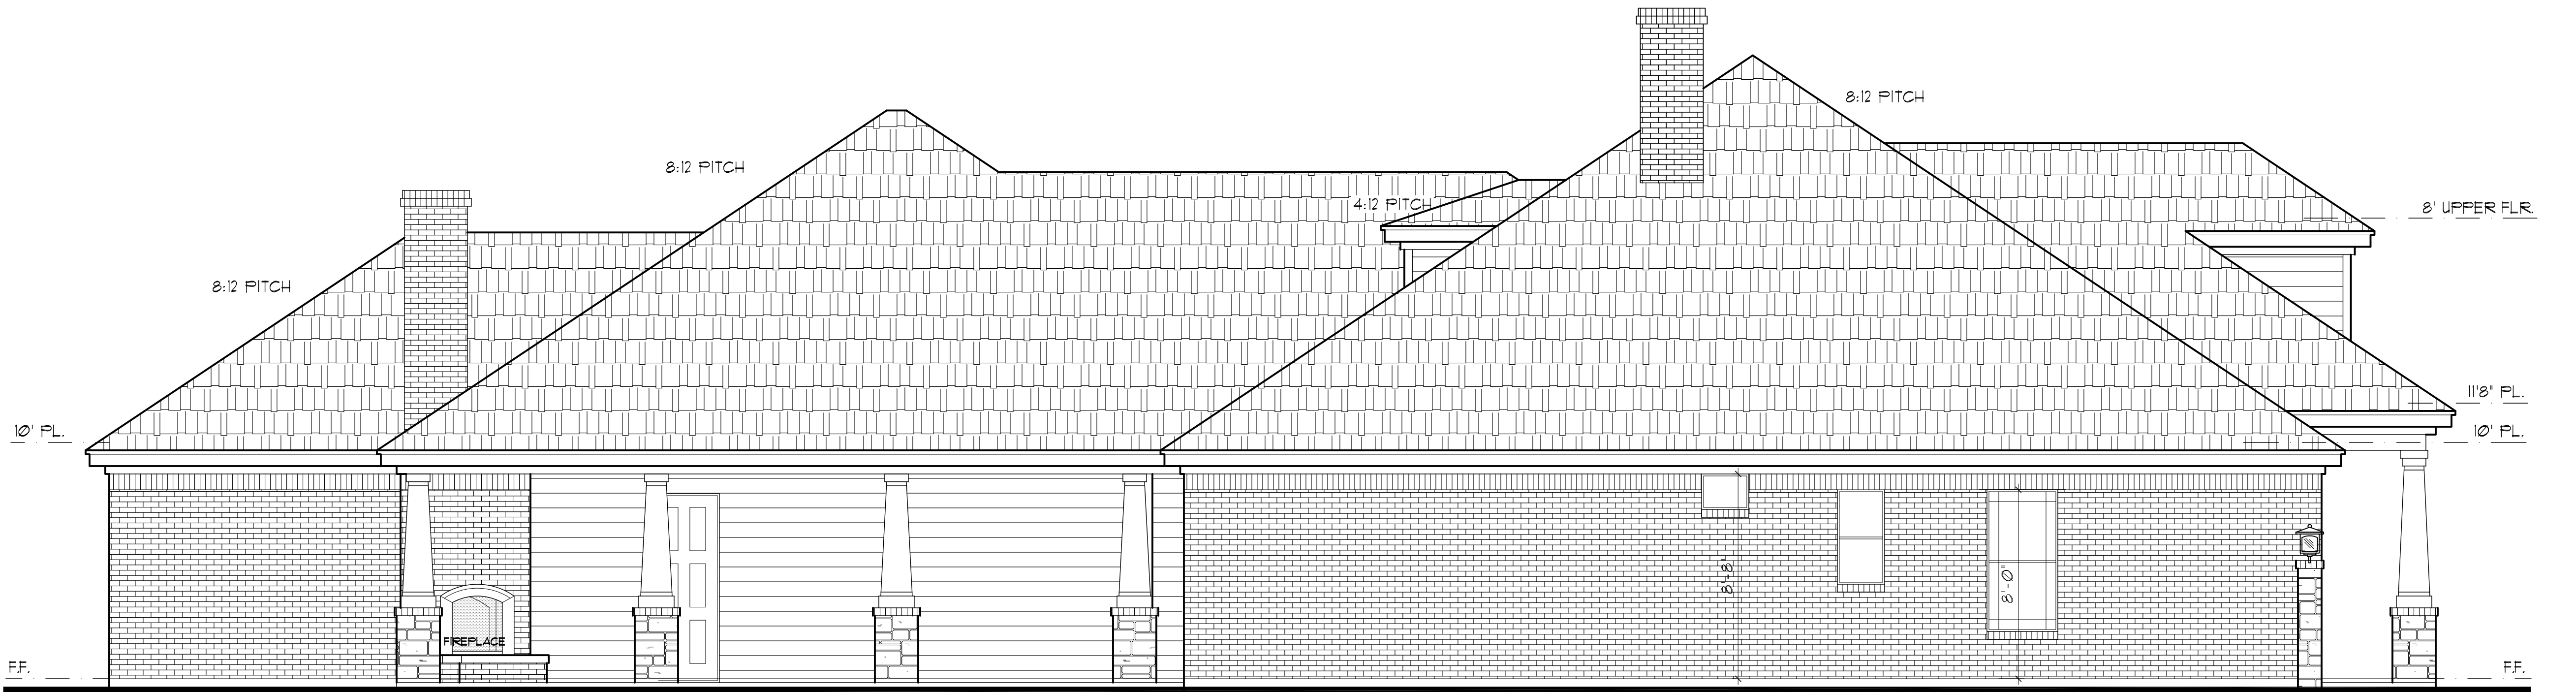

LEFT ELEVATION
SCALE: 1/4" = 1'-0"

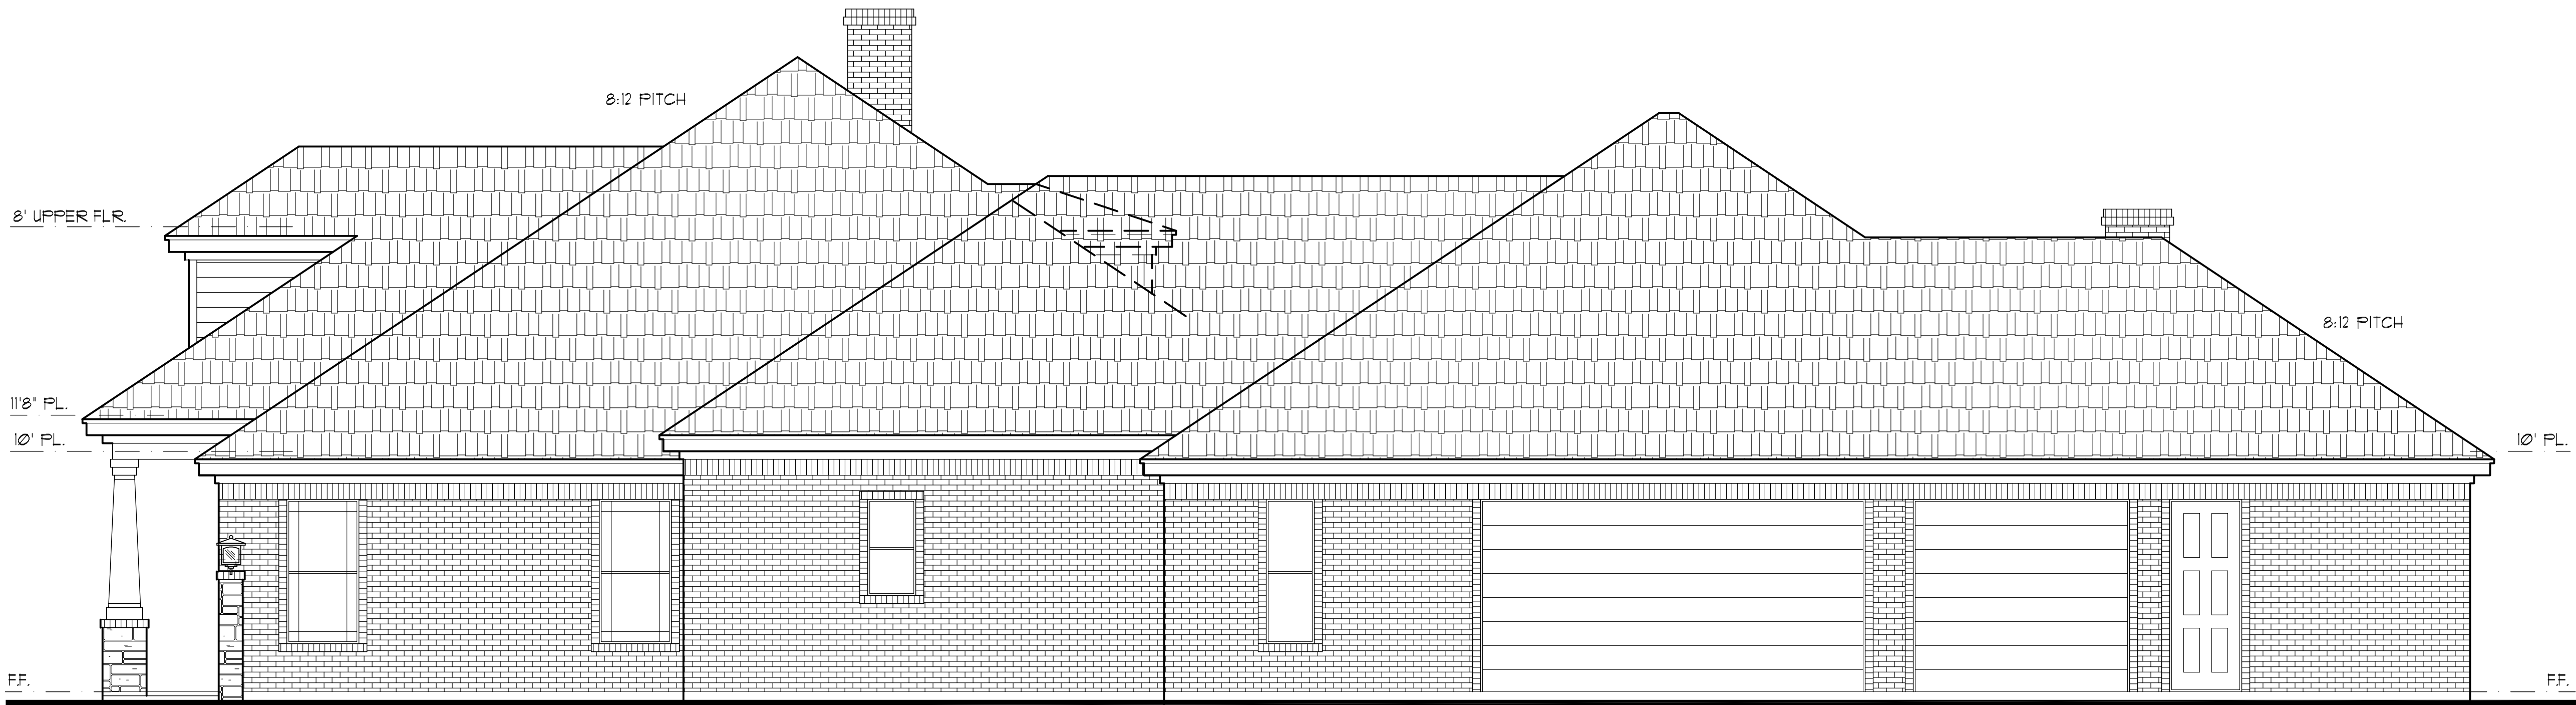

RIGHT ELEVATION
SCALE: 1/4" = 1'-0"

NOTE: IT IS THE SOLE RESPONSIBILITY OF THE BUILDER TO VERIFY ALL ASPECTS OF THIS PLAN AND TO ENSURE THAT THIS PLAN MEETS ALL GOVERNING CODES & REQUIREMENTS.

These plans are the property of "Direct Home Design" and are not to be reproduced, traced or reused without the written permission of "Direct Home Design". It shall be the responsibility of the builder/owner to verify all Deed Restrictions, Building Codes & Dimensions prior to any construction.




Direct Home Design
P.O. BOX 48631
Watauga, TX 76148
(817)917-4516

Direct Home Design
P.O. BOX 48631
Watauga, TX 76148
(817)917-4516

NOTE: IT IS THE SOLE RESPONSIBILITY OF THE BUILDER TO VERIFY ALL ASPECTS OF THIS PLAN AND TO ENSURE THAT THIS PLAN MEETS ALL GOVERNING CODES & REQUIREMENTS.

Drawn <u>WB</u>
Date <u>4-8-16</u>
PLAN NO.
BRIGHT
Pg. 3 OF 7

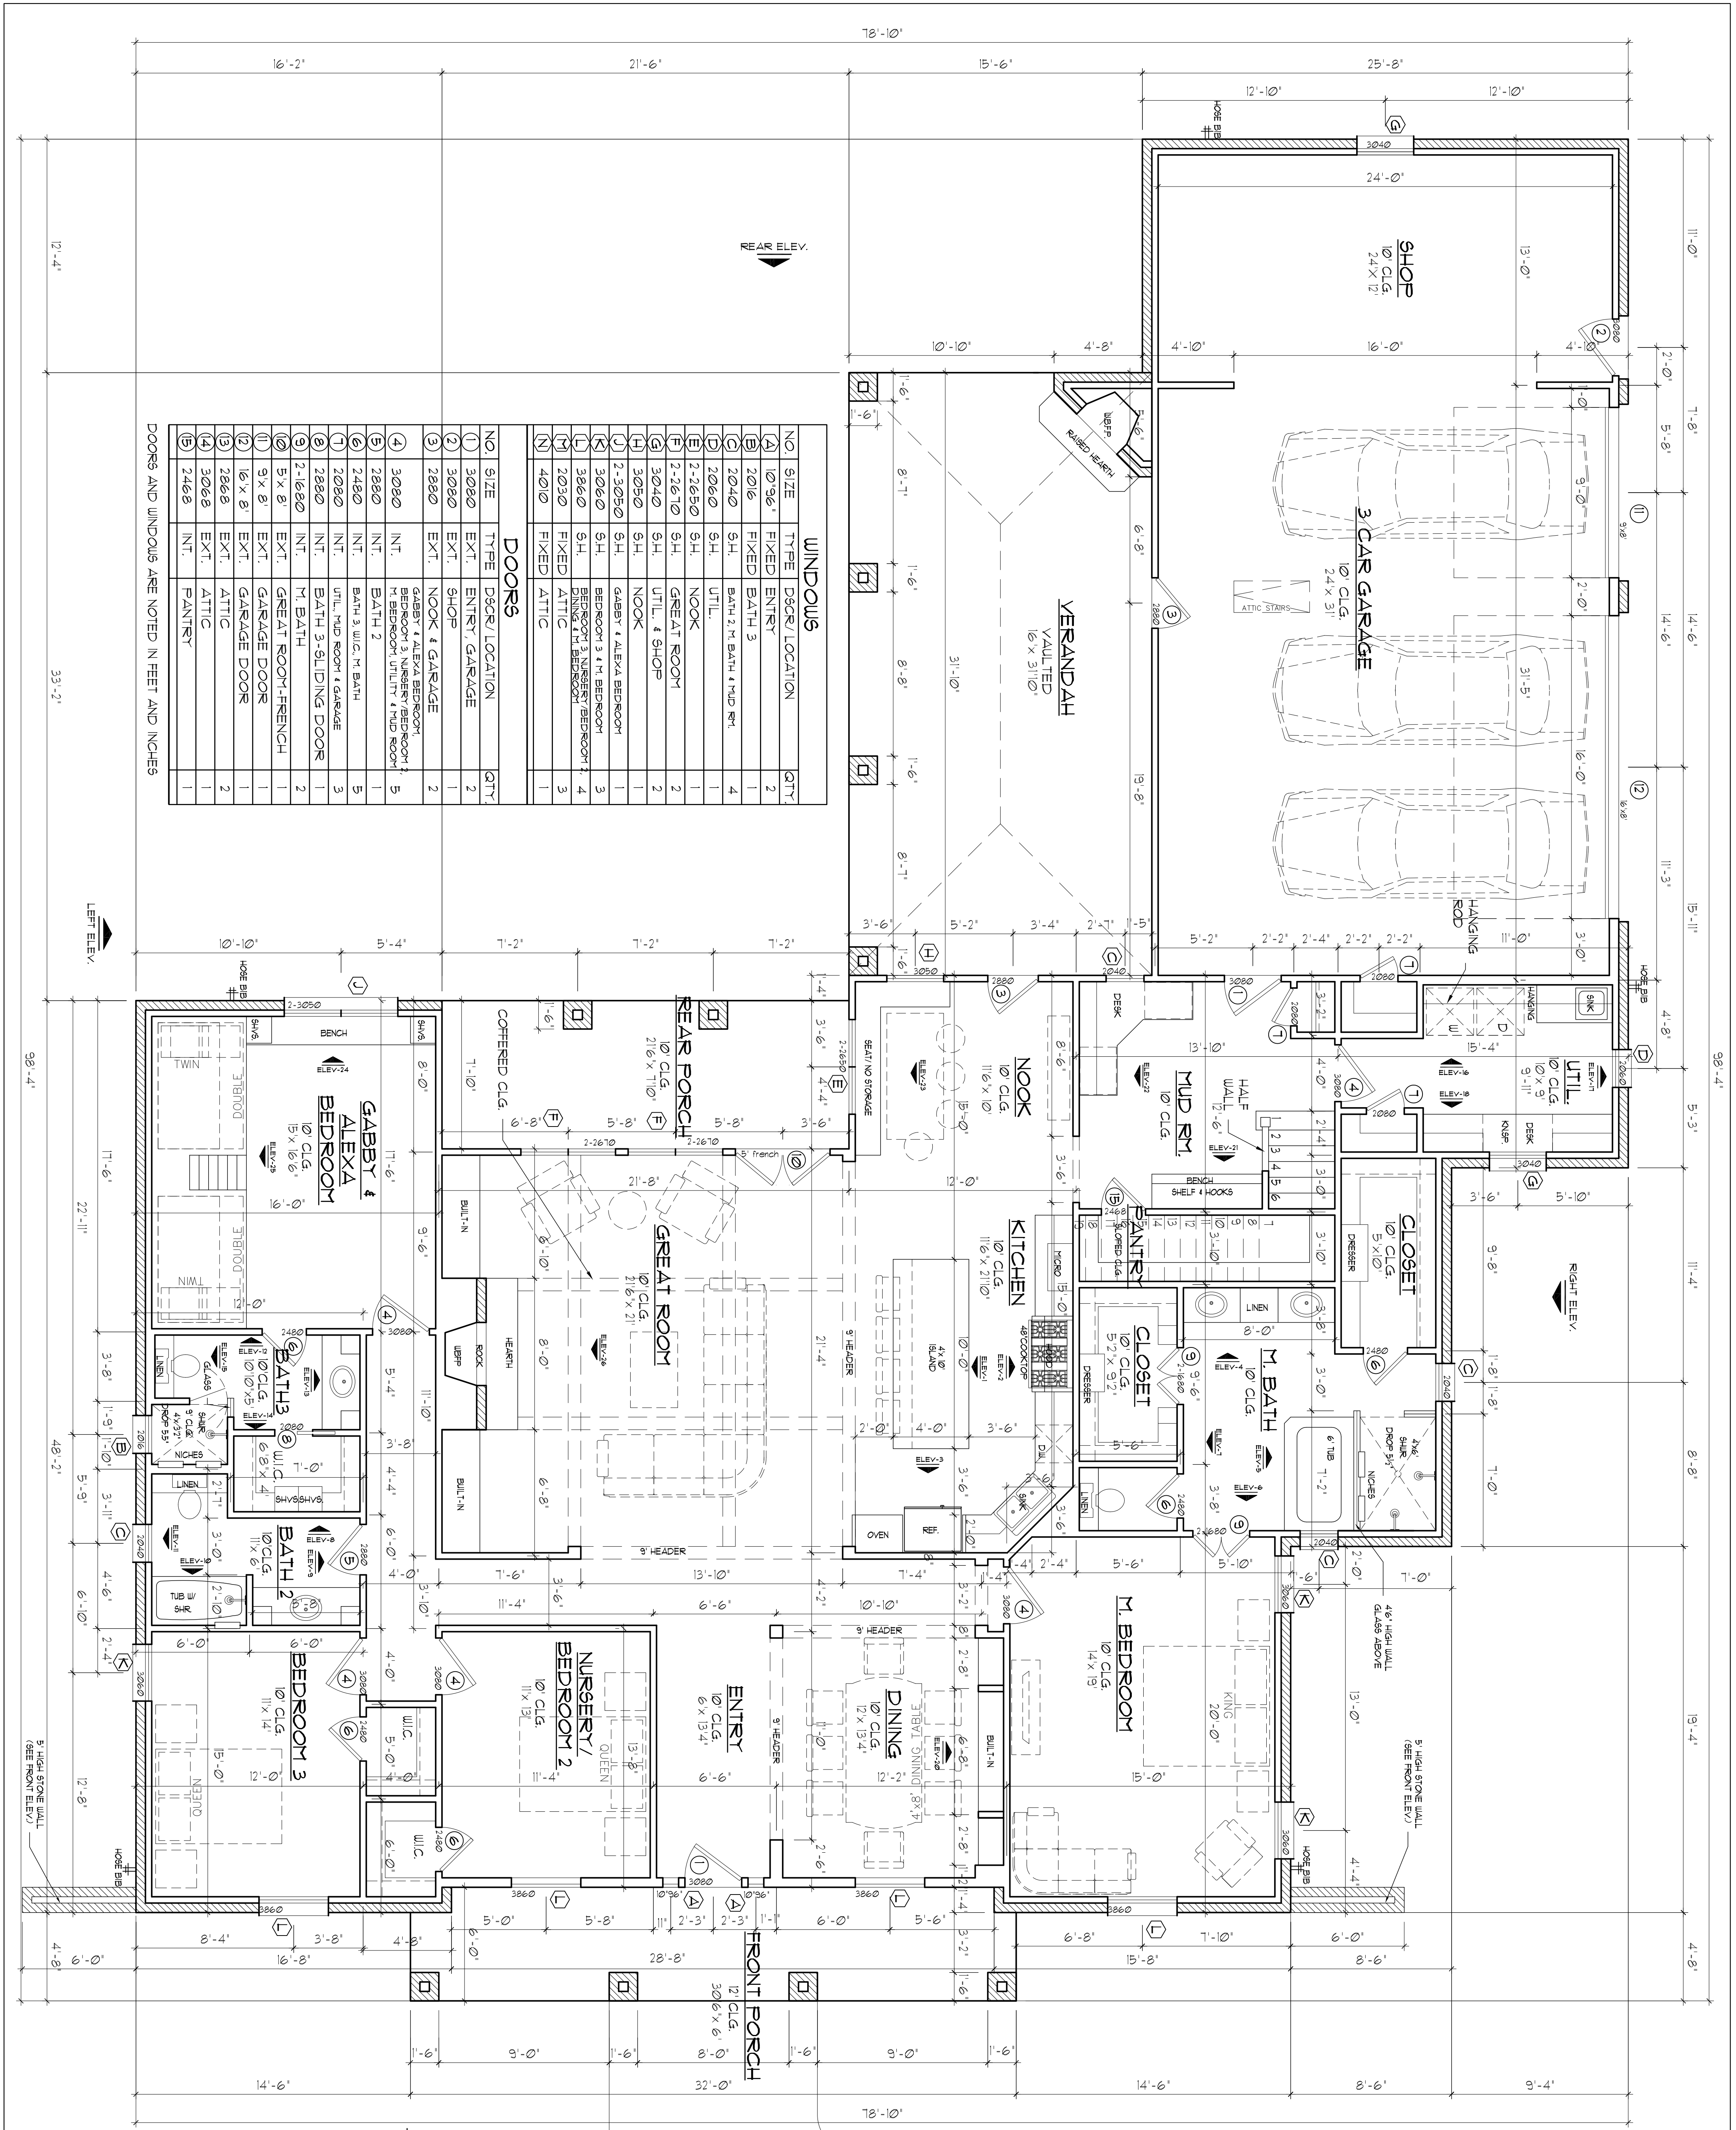

LOWER FLOOR PLAN
SCALE: 1/4" = 1'-0"